

SITE LIGHTING FIXTURE SCHEDULE - WALNUT ST PARKING									
TYPE	DESCRIPTION	MANUFACTURER	CATALOG NUMBER	LAMP TYPE	LAMP COLOR	LAMP QTY PER FIXTURE	VOLTAGE	WATTAGE	NOTES
YC	LED AREA LIGHT WITH 25' POLE AND 30" CONCRETE BASE	EATON MCGRAW EDISON	GLEON-AF-02-LED-E1-SLR-7030-800	LED	3000 K	1	277 V	85W	1

SITE LIGHTING SCHEDULE NOTES:

1. CONFIRM COLOR WITH ARCHITECT/OWNER. VERIFY ALL MOUNTING REQUIREMENTS.

PLAN NOTES: #

1. NEW 1 PHASE, 3 WIRE, 120/240V, 200A OUTDOOR METER PEDESTAL TO BE FURNISHED AND INSTALLED BY THE CONTRACTOR IN ACCORDANCE WITH THE ENERGY REQUIREMENTS. COORDINATE EXACT LOCATION WITH UTILITY COMPANY.
2. NEW 1 PHASE, 3 WIRE, 120/240V 100A UL LISTED FOR SERVICE ENTRANCE, NEMA 3R ENCLOSED COMBINATION MAIN FUSED DISCONNECT SWITCH WITH INTERNALLY MOUNTED ELECTRICALLY HEATED TYPE S LIGHTING CONTACTOR AND ELECTRONIC CONTROL TIMECLOCK. PROVIDE CONTROL OF FIXTURES IN THIS AREA BY PHOTOCLOCK ON/TIMECLOCK OFF.
3. CONTRACTOR IS TO PROVIDE SUITABLE GROUNDING AT NEW SERVICE IN ACCORDANCE WITH THE NATIONAL ELECTRICAL CODE.
4. CONTRACTOR IS TO PROVIDE UNDERGROUND BRANCH WIRING BETWEEN NEW SERVICE AND NEW SITE LIGHTING. PROVIDE 2 #6 & 1 #10G IN 1" PVC SCHEDULE 80 CONDUIT.

McGraw-Edison

DESCRIPTION: The GLEON™ LED luminaire delivers exceptional performance in a highly visible, low-profile design. Premium, high-efficiency Area LED fixtures - superior product quality and performance - provide superior lighting performance for the customer.

110 Light Square
Solid Brass LED
ANSI C136 CONFORMS

McGraw-Edison

DESCRIPTION: The GLEON™ LED luminaire delivers exceptional performance in a highly visible, low-profile design. Premium, high-efficiency Area LED fixtures - superior product quality and performance - provide superior lighting performance for the customer.

110 Light Square
Solid Brass LED
ANSI C136 CONFORMS

McGraw-Edison

DESCRIPTION: The GLEON™ LED luminaire delivers exceptional performance in a highly visible, low-profile design. Premium, high-efficiency Area LED fixtures - superior product quality and performance - provide superior lighting performance for the customer.

110 Light Square
Solid Brass LED
ANSI C136 CONFORMS

Beam Spread	1	2	3	4	5	6	7	8	9	10
Beam Spread	1.0	1.1	1.2	1.3	1.4	1.5	1.6	1.7	1.8	1.9
Beam Spread	1.0	1.1	1.2	1.3	1.4	1.5	1.6	1.7	1.8	1.9
McGraw-Edison

DESCRIPTION: The GLEON™ LED luminaire delivers exceptional performance in a highly visible, low-profile design. Premium, high-efficiency Area LED fixtures - superior product quality and performance - provide superior lighting performance for the customer.

110 Light Square
Solid Brass LED
ANSI C136 CONFORMS

McGraw-Edison

DESCRIPTION: The GLEON™ LED luminaire delivers exceptional performance in a highly visible, low-profile design. Premium, high-efficiency Area LED fixtures - superior product quality and performance - provide superior lighting performance for the customer.

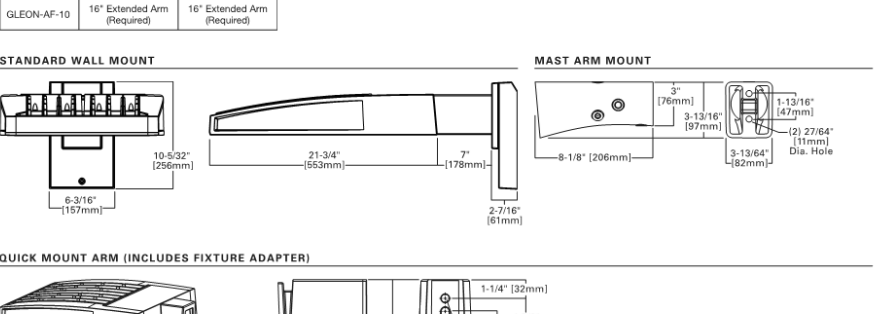
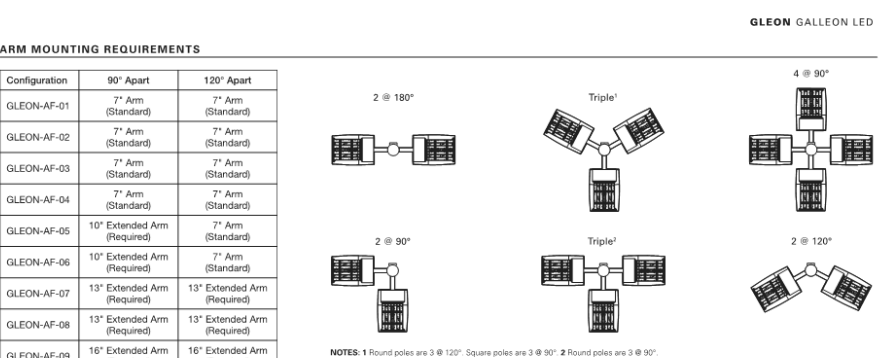
110 Light Square
Solid Brass LED
ANSI C136 CONFORMS

McGraw-Edison

DESCRIPTION: The GLEON™ LED luminaire delivers exceptional performance in a highly visible, low-profile design. Premium, high-efficiency Area LED fixtures - superior product quality and performance - provide superior lighting performance for the customer.

110 Light Square
Solid Brass LED
ANSI C136 CONFORMS

Beam Spread	1	2	3	4	5	6	7	8	9	10
Beam Spread	1.0	1.1	1.2	1.3	1.4	1.5	1.6	1.7	1.8	1.9
Beam Spread	1.0	1.1	1.2	1.3	1.4	1.5	1.6	1.7	1.8	1.9
McGraw-Edison

DESCRIPTION: The GLEON™ LED luminaire delivers exceptional performance in a highly visible, low-profile design. Premium, high-efficiency Area LED fixtures - superior product quality and performance - provide superior lighting performance for the customer.

110 Light Square
Solid Brass LED
ANSI C136 CONFORMS

Beam Spread	1	2	3	4	5	6	7	8	9	10
Beam Spread	1.0	1.1	1.2	1.3	1.4	1.5	1.6	1.7	1.8	1.9
Beam Spread	1.0	1.1	1.2	1.3	1.4	1.5	1.6	1.7	1.8	1.9
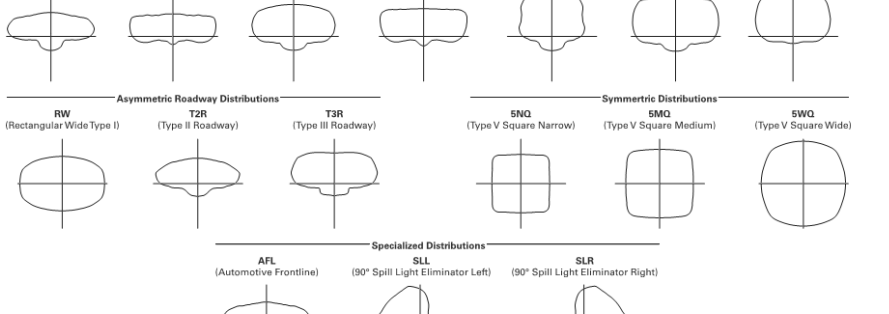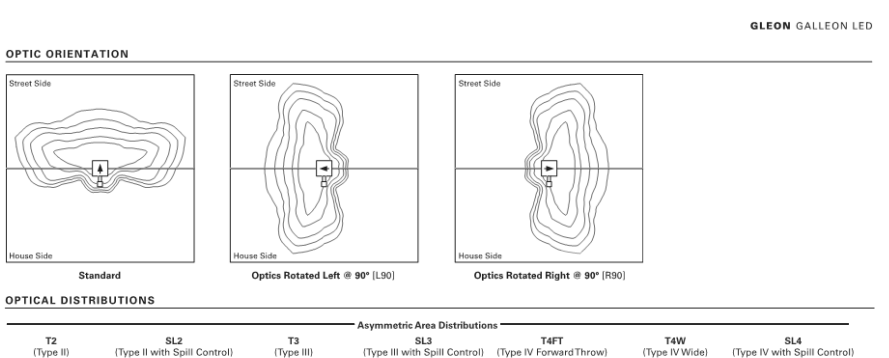


McGraw-Edison

DESCRIPTION: The GLEON™ LED luminaire delivers exceptional performance in a highly visible, low-profile design. Premium, high-efficiency Area LED fixtures - superior product quality and performance - provide superior lighting performance for the customer.

110 Light Square
Solid Brass LED
ANSI C136 CONFORMS

Beam Spread	1	2	3	4	5	6	7	8	9	10
Beam Spread	1.0	1.1	1.2	1.3	1.4	1.5	1.6	1.7	1.8	1.9
Beam Spread	1.0	1.1	1.2	1.3	1.4	1.5	1.6	1.7	1.8	1.9
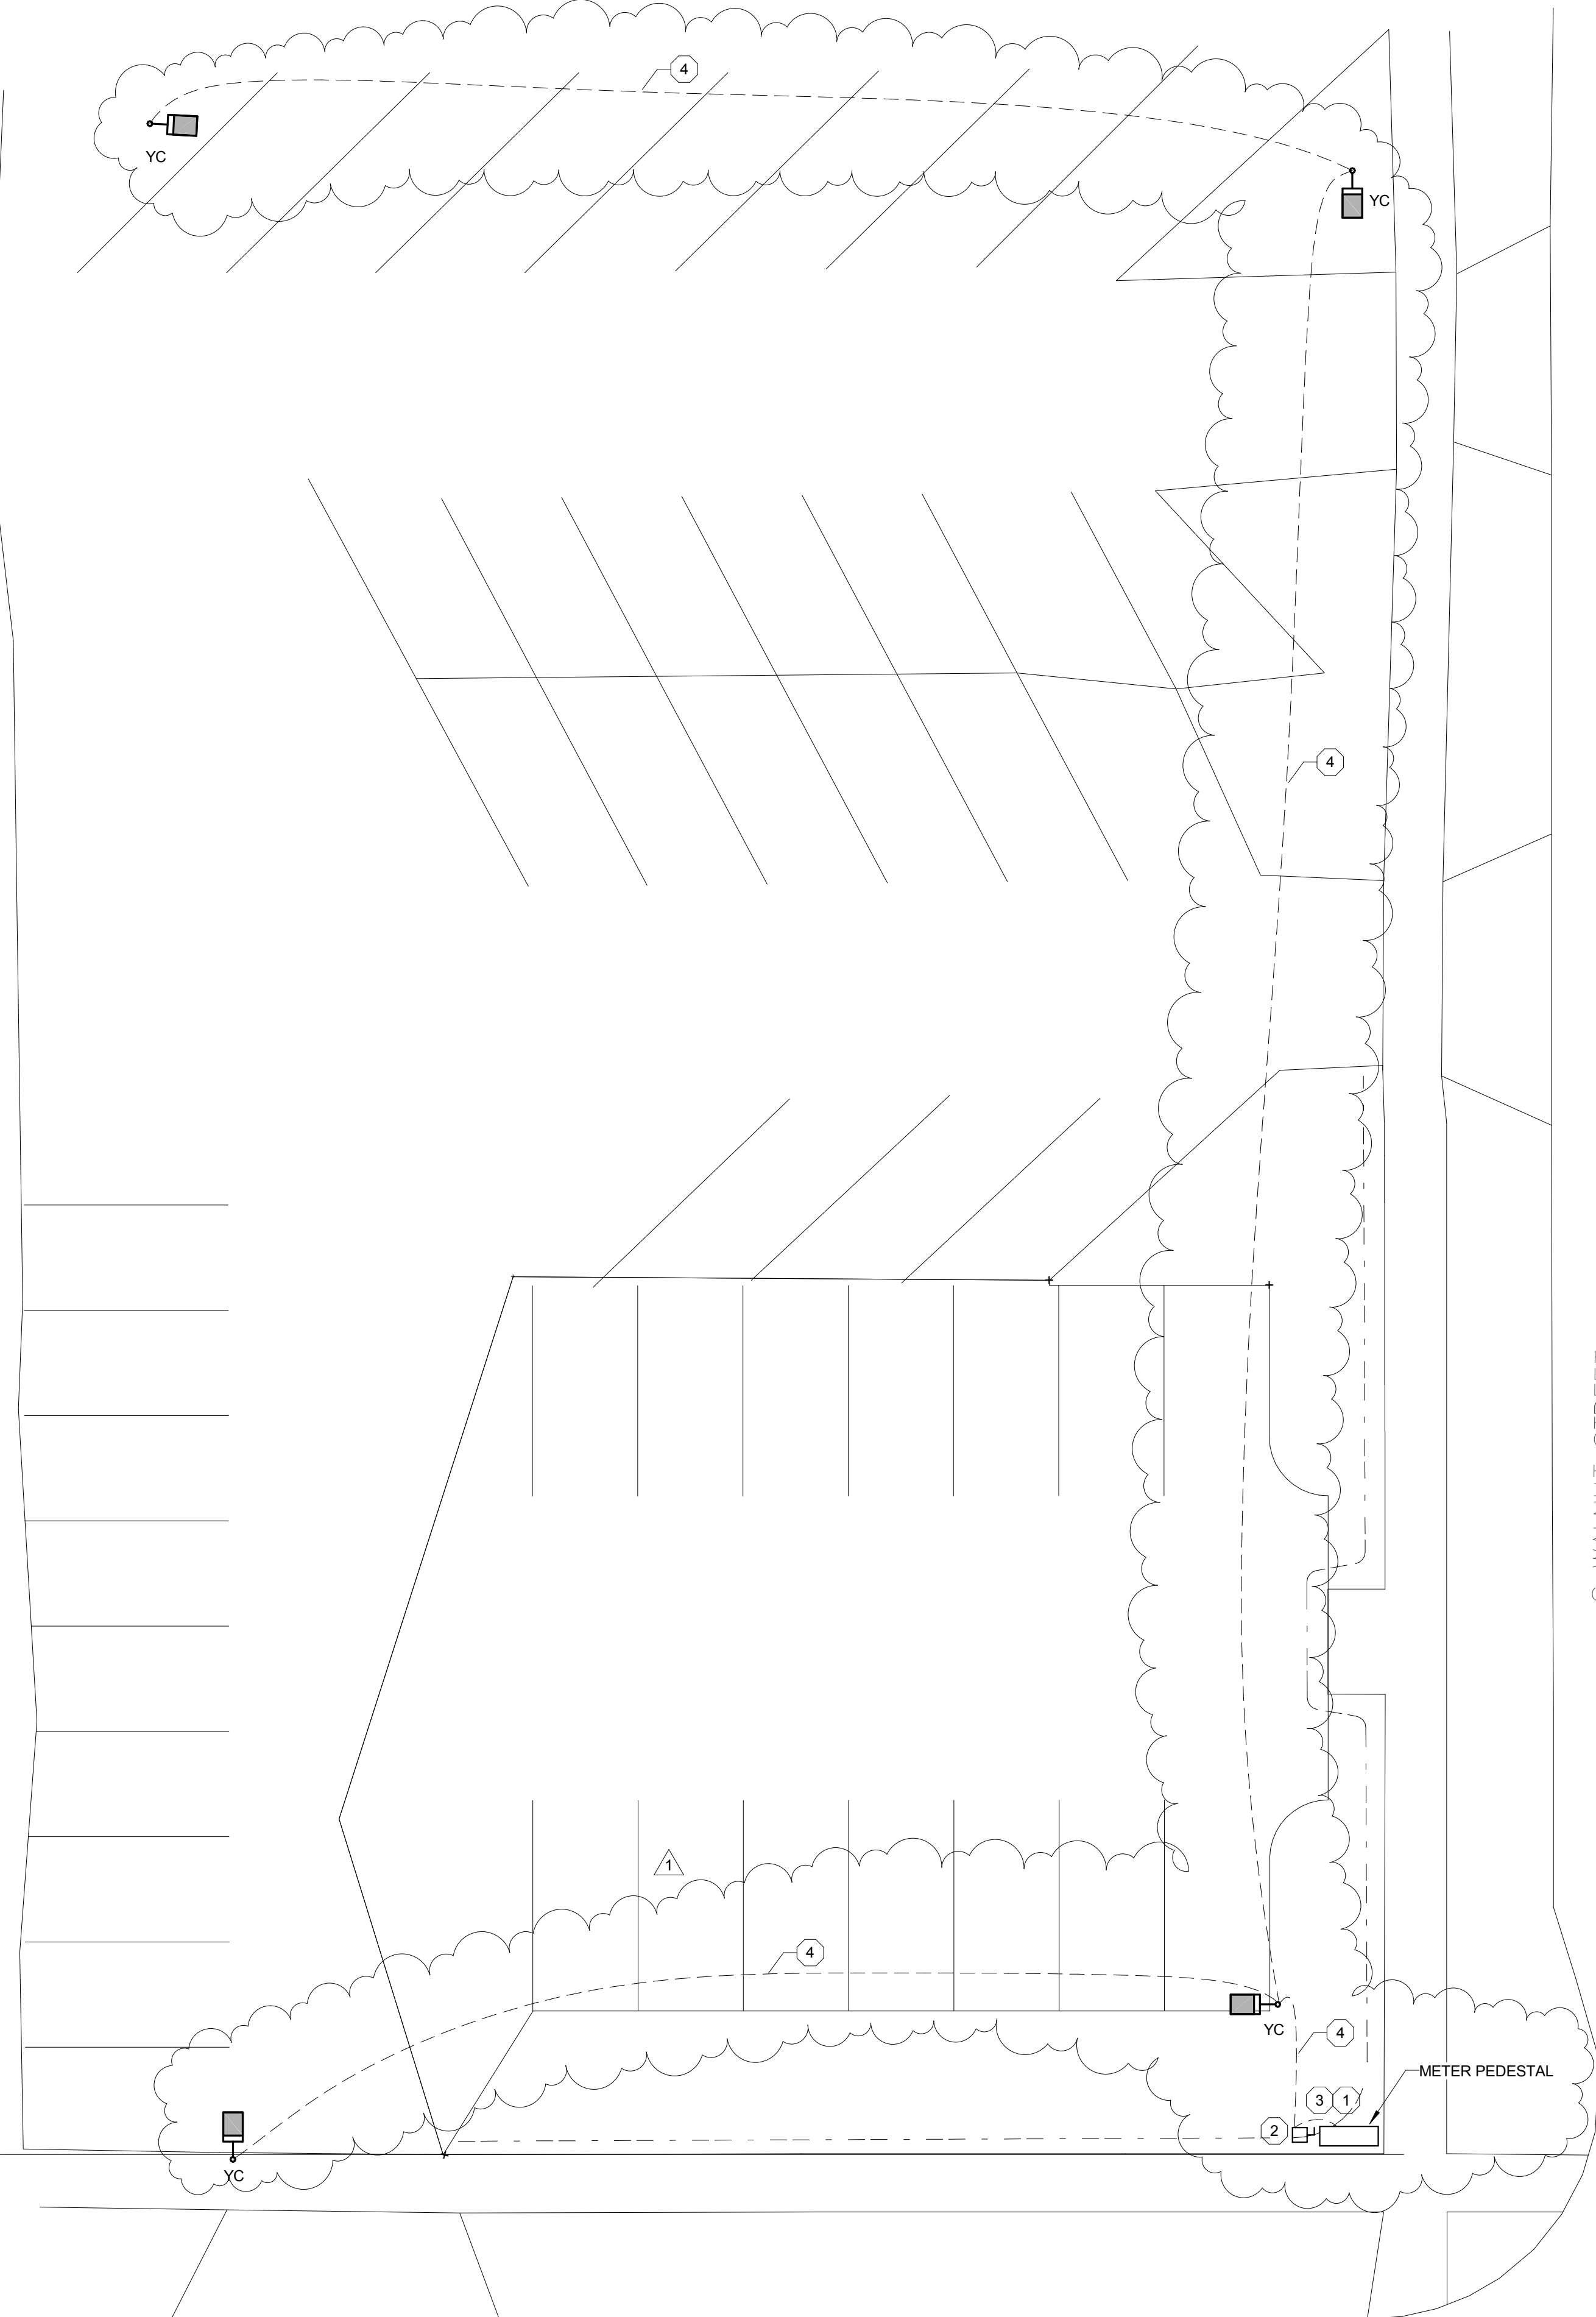

1 SITE ELECTRICAL PLAN-227 WALNUT
Scale: 1" = 10'-0"

McMAHON
ENGINEERS ARCHITECTS
P.O. BOX 1025
NEENAH, WI 54957-1025
Tel: (920) 751-4200 Fax: (920) 751-4284
www.mahon.com

McMahon provides this drawing as an instrument of service. All work is to be done in accordance with the contract documents prepared by McMahon. The client is responsible for obtaining all necessary permits and for obtaining all necessary approvals from the appropriate authorities. McMahon is not responsible for any errors or omissions in this drawing or for any consequences arising therefrom.

NO.	DATE	REVISION
1	3/31/17	Addendum #1

NO.	DATE	REVISION
1	3/31/17	Addendum #1

NO.	DATE	REVISION
1	3/31/17	Addendum #1

ALTERATION / ADDITION
OUTAGAME COUNTY ADMINISTRATION CENTER
S. WALNUT & W. 8TH, APPLETON WI 54911
SITE ELECTRICAL PLAN AND FIXTURE SCHEDULE

DESIGNED	DRAWN
CEH	MAL
PROJECT NO. 00002-61600160	
DATE MARCH 3, 2017	
SHEET NO. XE102	